


CANTERBURY ROAD

LEGEND

- ROAD PAVEMENT (REFER TO SHEET 1 FOR PAVEMENT DETAIL)
- 125mm THICK REINFORCED CONCRETE FOOTPATH (SD-F01)
- 200mm THICK REINFORCED CONCRETE VEHICLE CROSSING (SD-H05)
- ASPHALT FOOTPATH PAVEMENT
- STORMWATER DRAINAGE PIT AND PIPE TO COUNCIL STANDARDS
- CONCRETE KERB (VARIOUS PROFILES)
- PROPOSED PAVEMENT GRADE
- OVERLAND FLOW PATH
- PROPOSED PAVEMENT LINE MARKING
- EXISTING SURFACE CONTOURS (0.20m INTERVALS)
- PROPOSED FINISHED PAVEMENT SURFACE CONTOURS (0.10m INTERVALS)

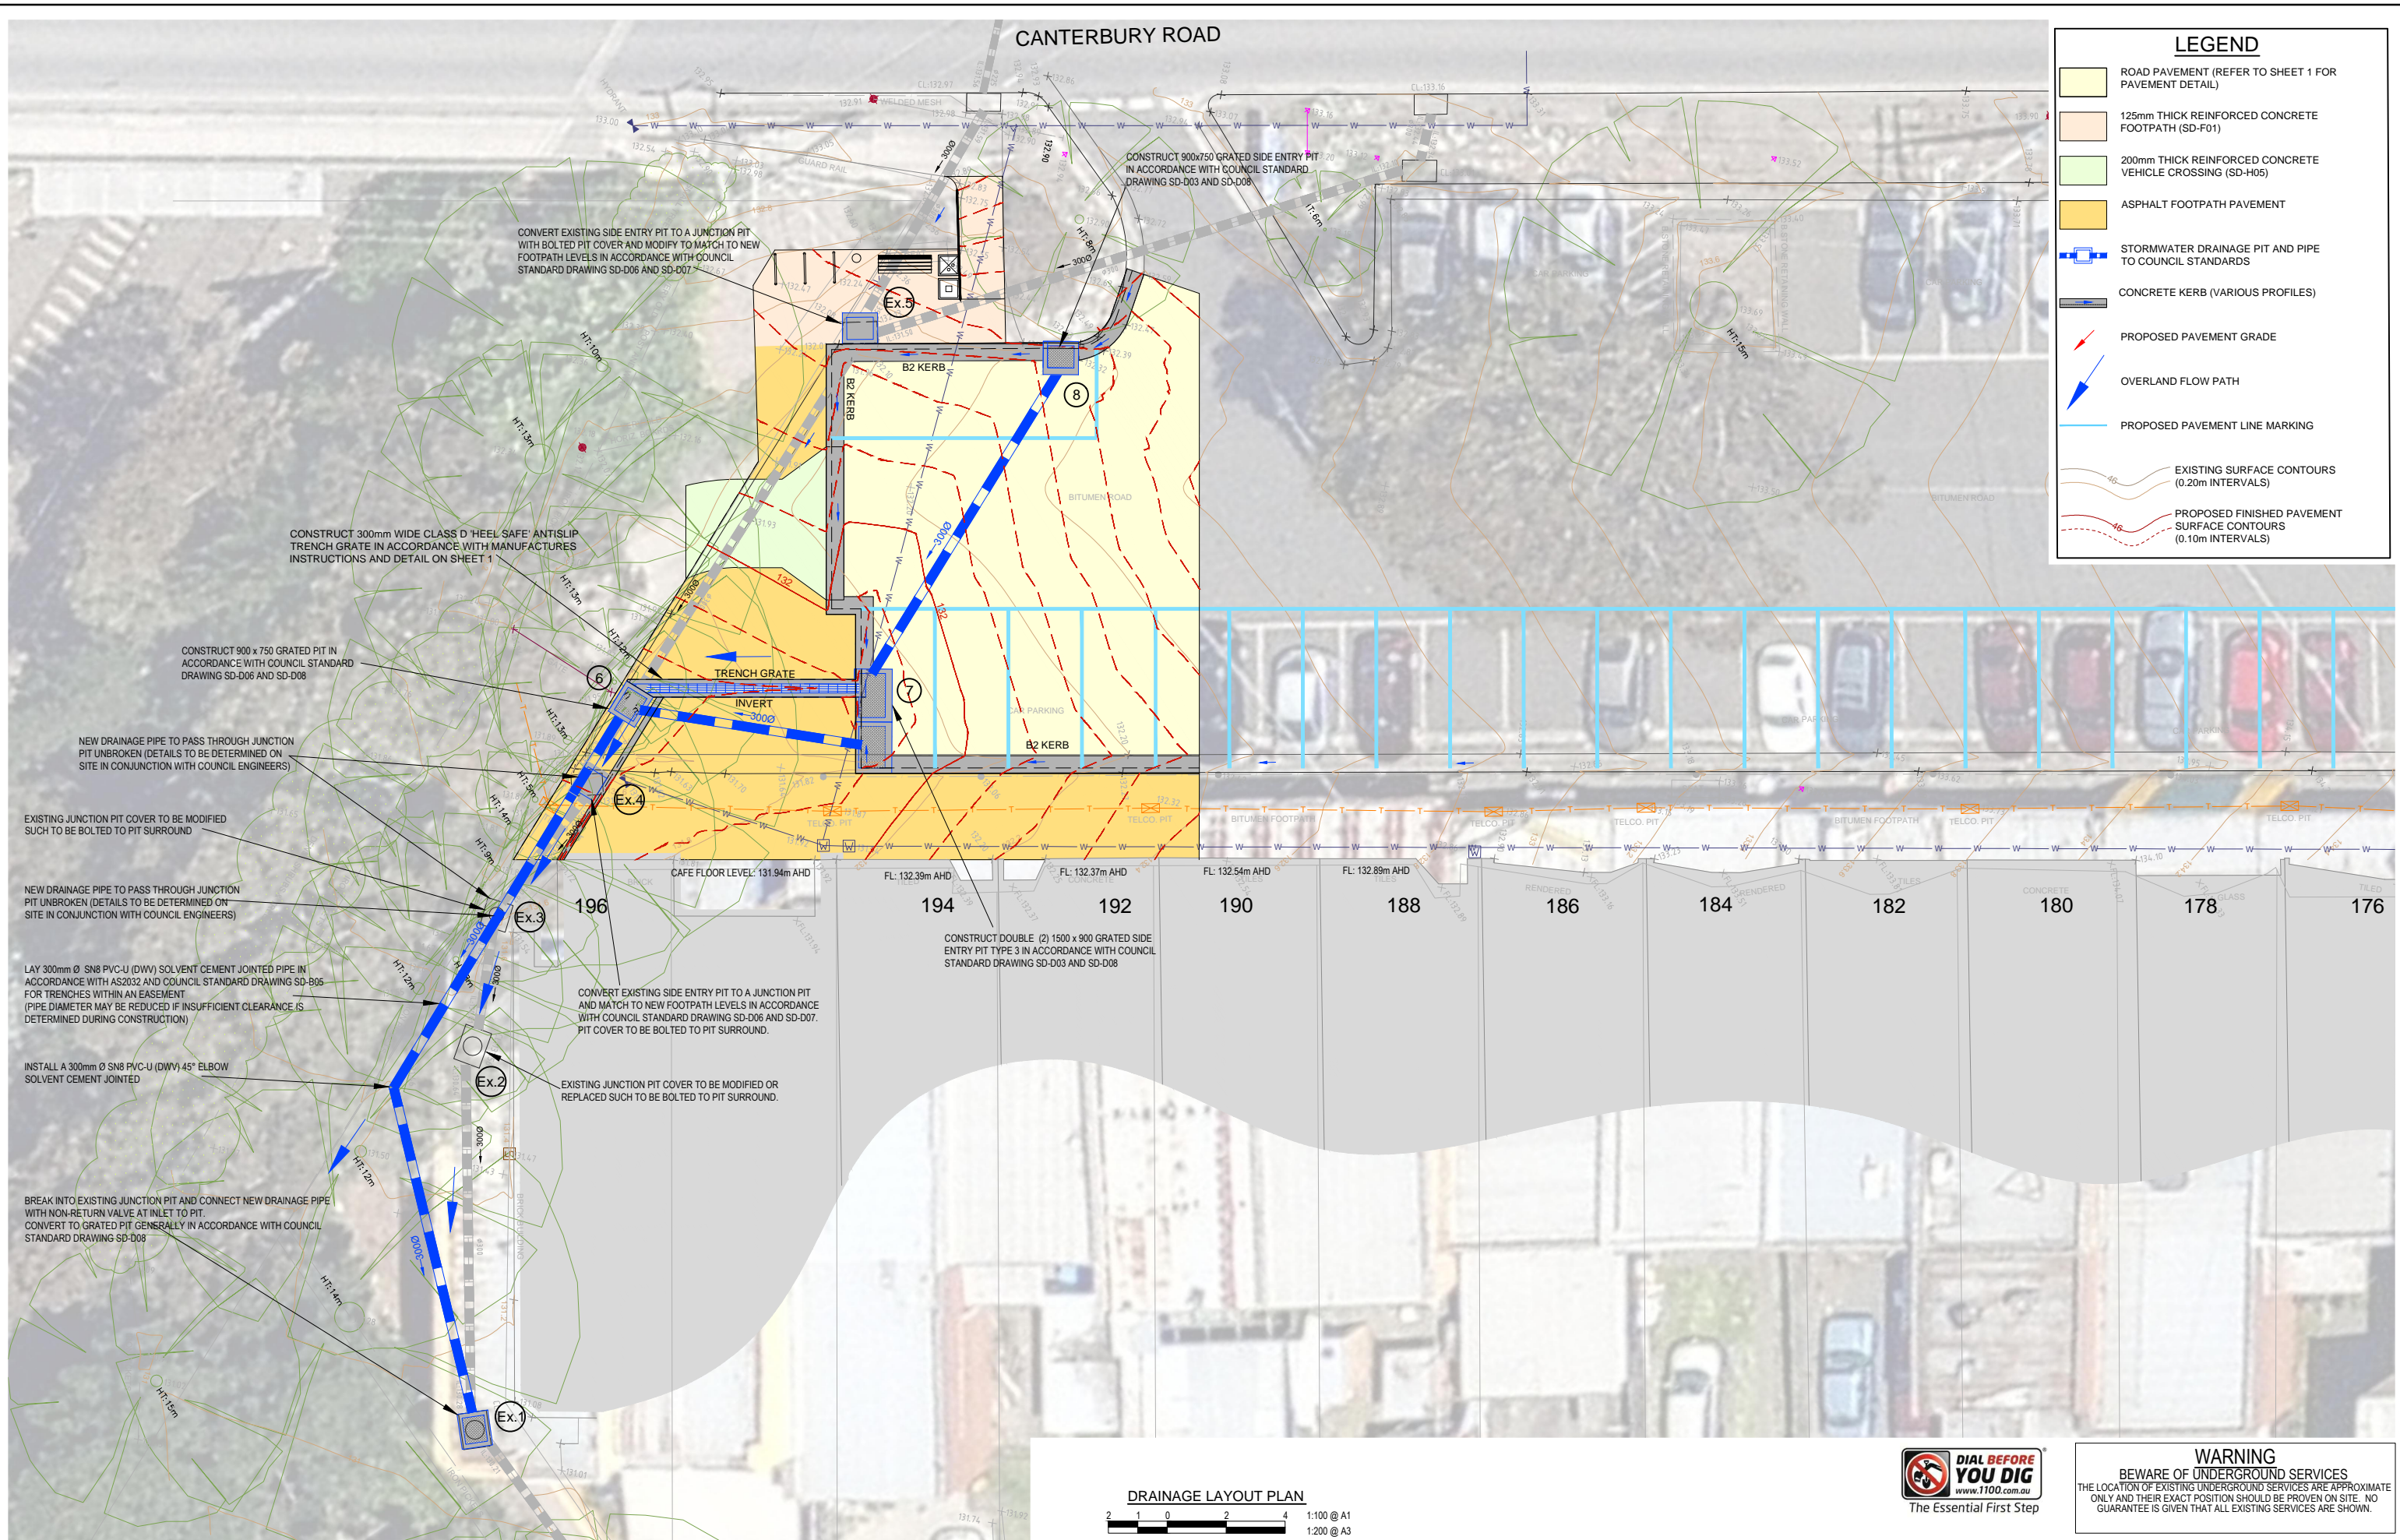

DRAINAGE LAYOUT PLAN
 1:100 @ A1
 1:200 @ A3



WARNING
 BEWARE OF UNDERGROUND SERVICES
 THE LOCATION OF EXISTING UNDERGROUND SERVICES ARE APPROXIMATE ONLY AND THEIR EXACT POSITION SHOULD BE PROVEN ON SITE. NO GUARANTEE IS GIVEN THAT ALL EXISTING SERVICES ARE SHOWN.

VER	DESCRIPTION	DATE	APP
05	DETAILED DESIGN	09-02-2018	-
04	DETAILED DESIGN	05-02-2018	-
03	DRAFT DETAILED DESIGN - FOR REVIEW	01-02-2018	-
02	REVISED FUNCTIONAL DESIGN - FOR REVIEW	03-11-2017	-
01	REVISED FUNCTIONAL DESIGN - FOR REVIEW	02-08-2017	-
00	ORIGINAL ISSUE - FUNCTIONAL DESIGN - FOR REVIEW	04-07-2017	-

HEIGHT DATUM	LATEST ISSUE DATE
AHD	09-02-2018
COORDINATE DATUM	ENGINEERING DESIGN
MGA zone 55	CHRIS PROCTOR
CONSTRUCTION	DRAFTING
	CHRIS PROCTOR
	CHECKED
	APPROVED
SCALE	
1:100 @ A1	
1:200 @ A3	



ENGINEERING & BUILDING SERVICES

MAROONDAY CITY COUNCIL
 BRAESIDE AVENUE RINGWOOD VIC 3134
 PO Box 156 RINGWOOD VIC 3134
 PHONE: 1300 88 22 33 or (03) 9298 4598
 EMAIL: maroondah@maroondah.vic.gov.au
 WEB: www.maroondah.vic.gov.au

DETAILED DESIGN

CAR PARK DRAINAGE UPGRADE WORKS
 HEATHMONT SHOPPING CENTRE, HEATHMONT

DRAINAGE LAYOUT PLAN

PLAN No: M12
 SHEET No: 03 OF 07
 VER: 05
 DWG No: M12-03-05